



2974 S.E. LOOP B20
FORT WORTH, TX. 76140
817-572-0391

Panel Label: H-REF, Voltage: 277/480, Section: 1 of 2, Name: 1. Main Type: MLO 22 KAC, Man Bus Size: 150A. Table with columns for VA Load, Trip Size, # of Spaces, and Load Served. Includes summary table for VA per phase and Amps per phase.

Panel Label: HS, Voltage: 277/480, Section: 1 of 2, Name: 1. Main Type: MLO 22 KAC, Man Bus Size: 150A. Table with columns for VA Load, Trip Size, # of Spaces, and Load Served. Includes summary table for VA per phase and Amps per phase.

Panel Label: HN, Voltage: 277/480, Section: 1 of 2, Name: 1. Main Type: MLO 22 KAC, Man Bus Size: 150A. Table with columns for VA Load, Trip Size, # of Spaces, and Load Served. Includes summary table for VA per phase and Amps per phase.

Panel Label: H-OF, Voltage: 277/480, Section: 1 of 2, Name: 1. Main Type: MLO 22 KAC, Man Bus Size: 225A. Table with columns for VA Load, Trip Size, # of Spaces, and Load Served. Includes summary table for VA per phase and Amps per phase.

Panel Label: L-REF, Voltage: 120/208, Section: 1 of 2, Name: 1. Main Type: MCB 10 KAC, Man Bus Size: 60A. Table with columns for VA Load, Trip Size, # of Spaces, and Load Served. Includes summary table for VA per phase and Amps per phase.

Panel Label: LS, Voltage: 120/208, Section: 1 of 2, Name: 1. Main Type: MCB 10 KAC, Man Bus Size: 60A. Table with columns for VA Load, Trip Size, # of Spaces, and Load Served. Includes summary table for VA per phase and Amps per phase.

Panel Label: LN, Voltage: 120/208, Section: 1 of 2, Name: 1. Main Type: MCB 10 KAC, Man Bus Size: 100A. Table with columns for VA Load, Trip Size, # of Spaces, and Load Served. Includes summary table for VA per phase and Amps per phase.


Panel Label: L-OF, Voltage: 120/208, Section: 1 of 2, Name: 1. Main Type: MCB 10 KAC, Man Bus Size: 150A. Table with columns for VA Load, Trip Size, # of Spaces, and Load Served. Includes summary table for VA per phase and Amps per phase.

Panel Label: CHGR - Section 2, Voltage: 480, Section: 2 of 2, Name: 1. Main Type: MLO 14 KAC, Man Bus Size: 400A. Table with columns for VA Load, Trip Size, # of Spaces, and Load Served. Includes summary table for VA per phase and Amps per phase.

Panel Label: CHGR - Section 1, Voltage: 480, Section: 1 of 2, Name: 1. Main Type: MLO 14 KAC, Man Bus Size: 400A. Table with columns for VA Load, Trip Size, # of Spaces, and Load Served. Includes summary table for VA per phase and Amps per phase.

Panel Label: WHS, Voltage: 277/480, Section: 1 of 2, Name: 1. Main Type: MLO 22 KAC, Man Bus Size: 300A. Table with columns for VA Load, Trip Size, # of Spaces, and Load Served. Includes summary table for VA per phase and Amps per phase.

Panel Label: MSB, Voltage: 277/480, Section: 1 of 2, Name: NT. Main Type: MLO 35 KAC, Man Bus Size: 2000A. Table with columns for VA Load, Trip Size, # of Spaces, and Load Served. Includes summary table for VA per phase and Amps per phase.

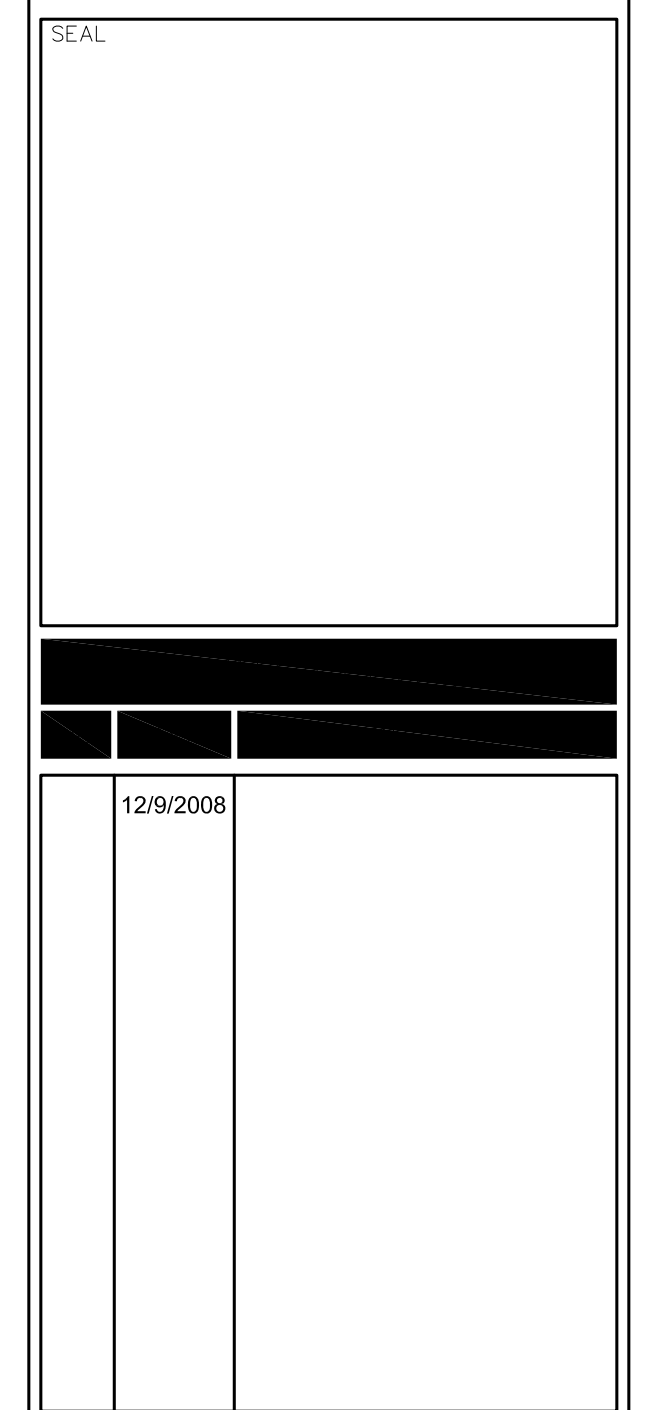

MULTI-TENANT INVENTORY AND DISTRIBUTION CENTER FOR
ARLINGTON COMMERCE CENTER
VISTAR
4905 NEW YORK AVE.
ARLINGTON, TEXAS 76018

General Contractor:
KBD CONSTRUCTION SERVICES
1431 Greenway, Suite 740
Irving, Texas 75038

Architect:
MACGREGOR ASSOCIATES
ARCHITECTS
2830 Paces Ferry Rd. NW, Suite 500
Atlanta, Georgia 30339

MULTI-TENANT INVENTORY AND DISTRIBUTION CENTER FOR

PANEL SCHEDULES

* See riser diagram

SHEET NUMBER
E8

11/20/2008 8:46:32 AM

1